


WL - ORR Minimalist Round Outdoor Wall Lamp

Part Code	ORR
Diffuser	Warm White
Dimensions (mm)	230mm
Construction	Metal
Finish	Metal
Class	/
IP Rating	IP65
Maximum Wattage	/
Lamp Base	SMD
Dimmable	No
Input Voltage	110V - 240V
Net Weight (g)	/
Gross Weight (g)	/
Warranty	1-3 Years
Origin of Manufacture	Lassola

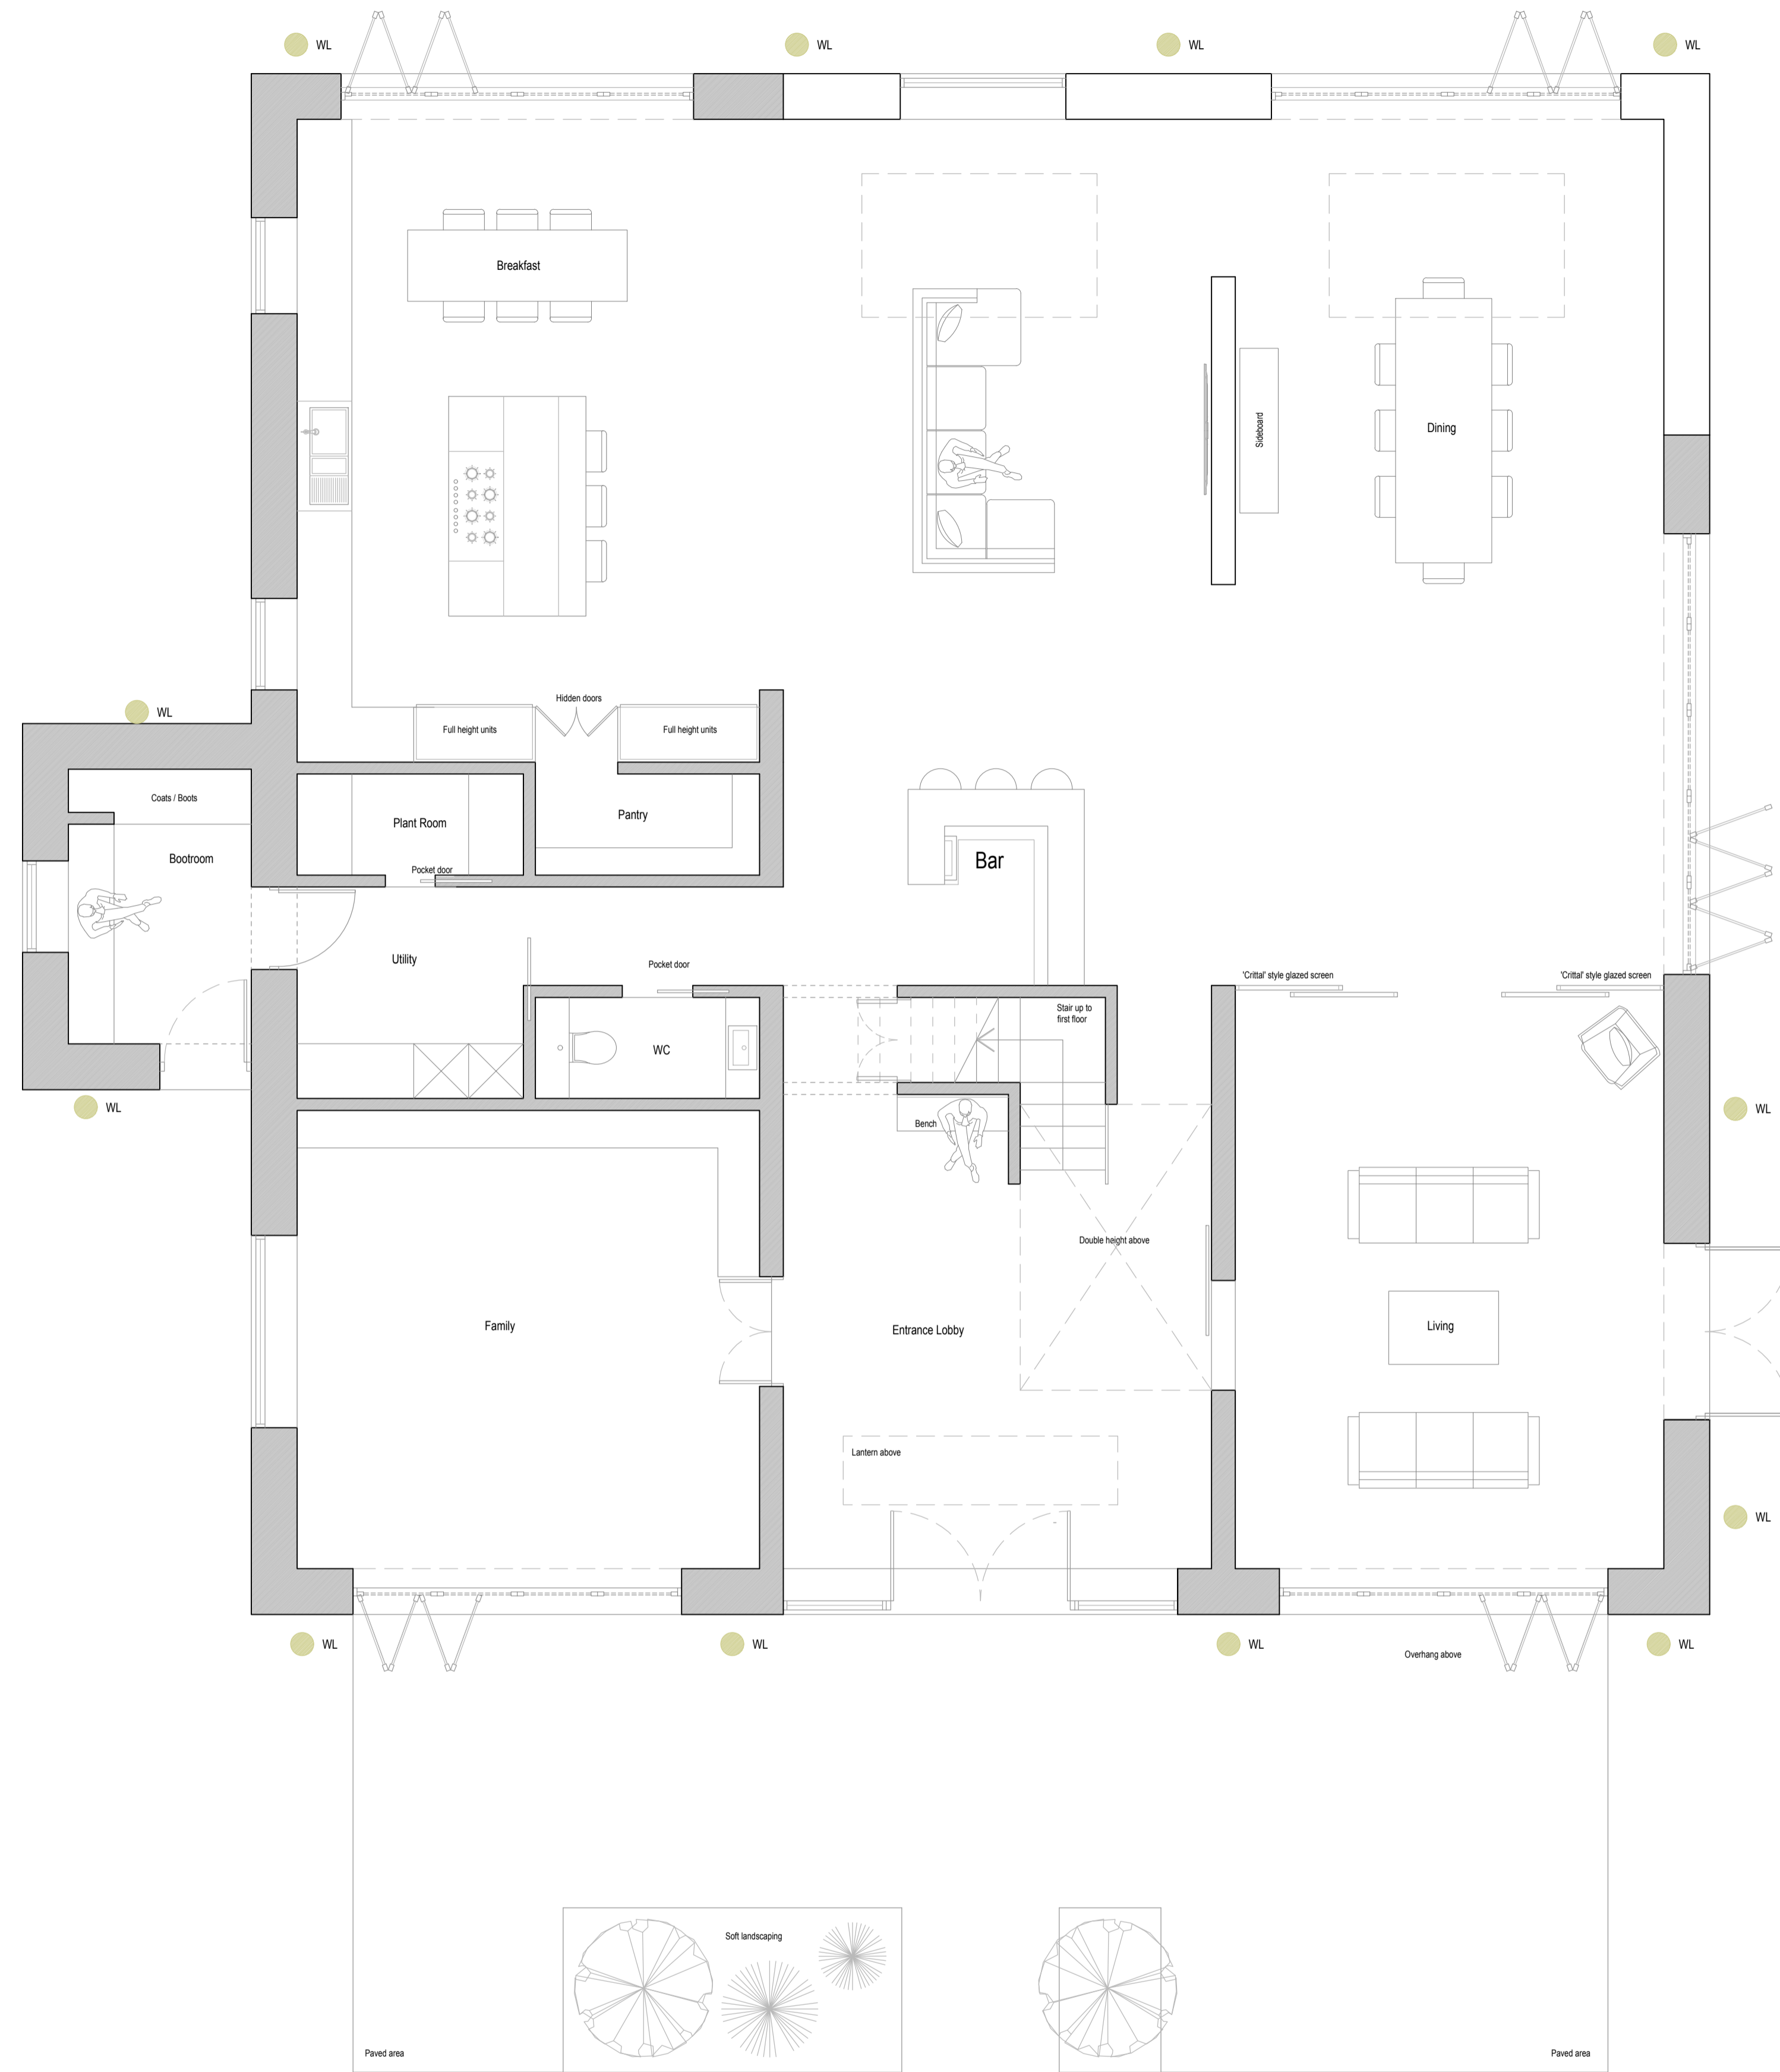

External Ground Floor Lighting Plan
Scale 1:50

Notes
Do Not Scale (unless for the purposes of planning). Report all discrepancies, errors and omissions. Verify all dimensions on site before commencing any work on site or preparing shop drawings. All materials, components and workmanship are to comply with the relevant British Standards, Codes of Practice, and appropriate manufacturers recommendations that from time to time shall apply. For all specialist work, see relevant drawings. This drawing is copyright of Kent Design Studio Ltd

CDM 2015
Under the CDM regulations 2015, the client will need to employ a principal designer and principal contractor to assist in the health and safety process and co-ordinate health and safety matters. Further advice with regards to the clients duties and the duties of the principal designer & principal contractor can be found on the Internet (such as CONIAC Industry Guidance & HSE website), or alternatively you should take advice from a suitably qualified company. This drawing, together with an asbestos survey or any other surveys and record drawings / information that the client has on the building or site such as service locations should be passed on to the contractor. Our brief does not extend to principal designer role, so the principal contractor will be responsible for developing health and safety file during construction and handing it over to the client as an as built health and safety file.

Rev	Date	Description

Scale 1:50

Scale 1:50 @ A1

KENT DESIGN STUDIO **KDS**
web - www.kentdesignstudio.co.uk tel - 01580 230413

Scale 1:50 @ A1

Date September 2025

PLANNING

Project Title
Proposed Replacement Dwelling at
Ferndale
Biddenden
Ashford
TN27 8DW

Description
Ground & First floor
External Lighting Plan

Drawing Number
2683 270